



38 Beaver Brook Road  
Danbury CT 06810  
www.rosssolargroup.com  
PH: 203.512.4500  
FX: 866 271-3016

CONSULTANT

REVISION

NUMBER:	DATE:	ISSUED FOR:
1	10-18-13	Interconnect

West Stafford Elementary  
135 West Stafford Road  
Stafford CT 06076

DRAWN BY:

Andy Mayshar

DRAWING TITLE:


PHOTOVOLTAIC  
ELECTRICAL PLAN

DATE

11-18-2013

SHEET NUMBER

E-3

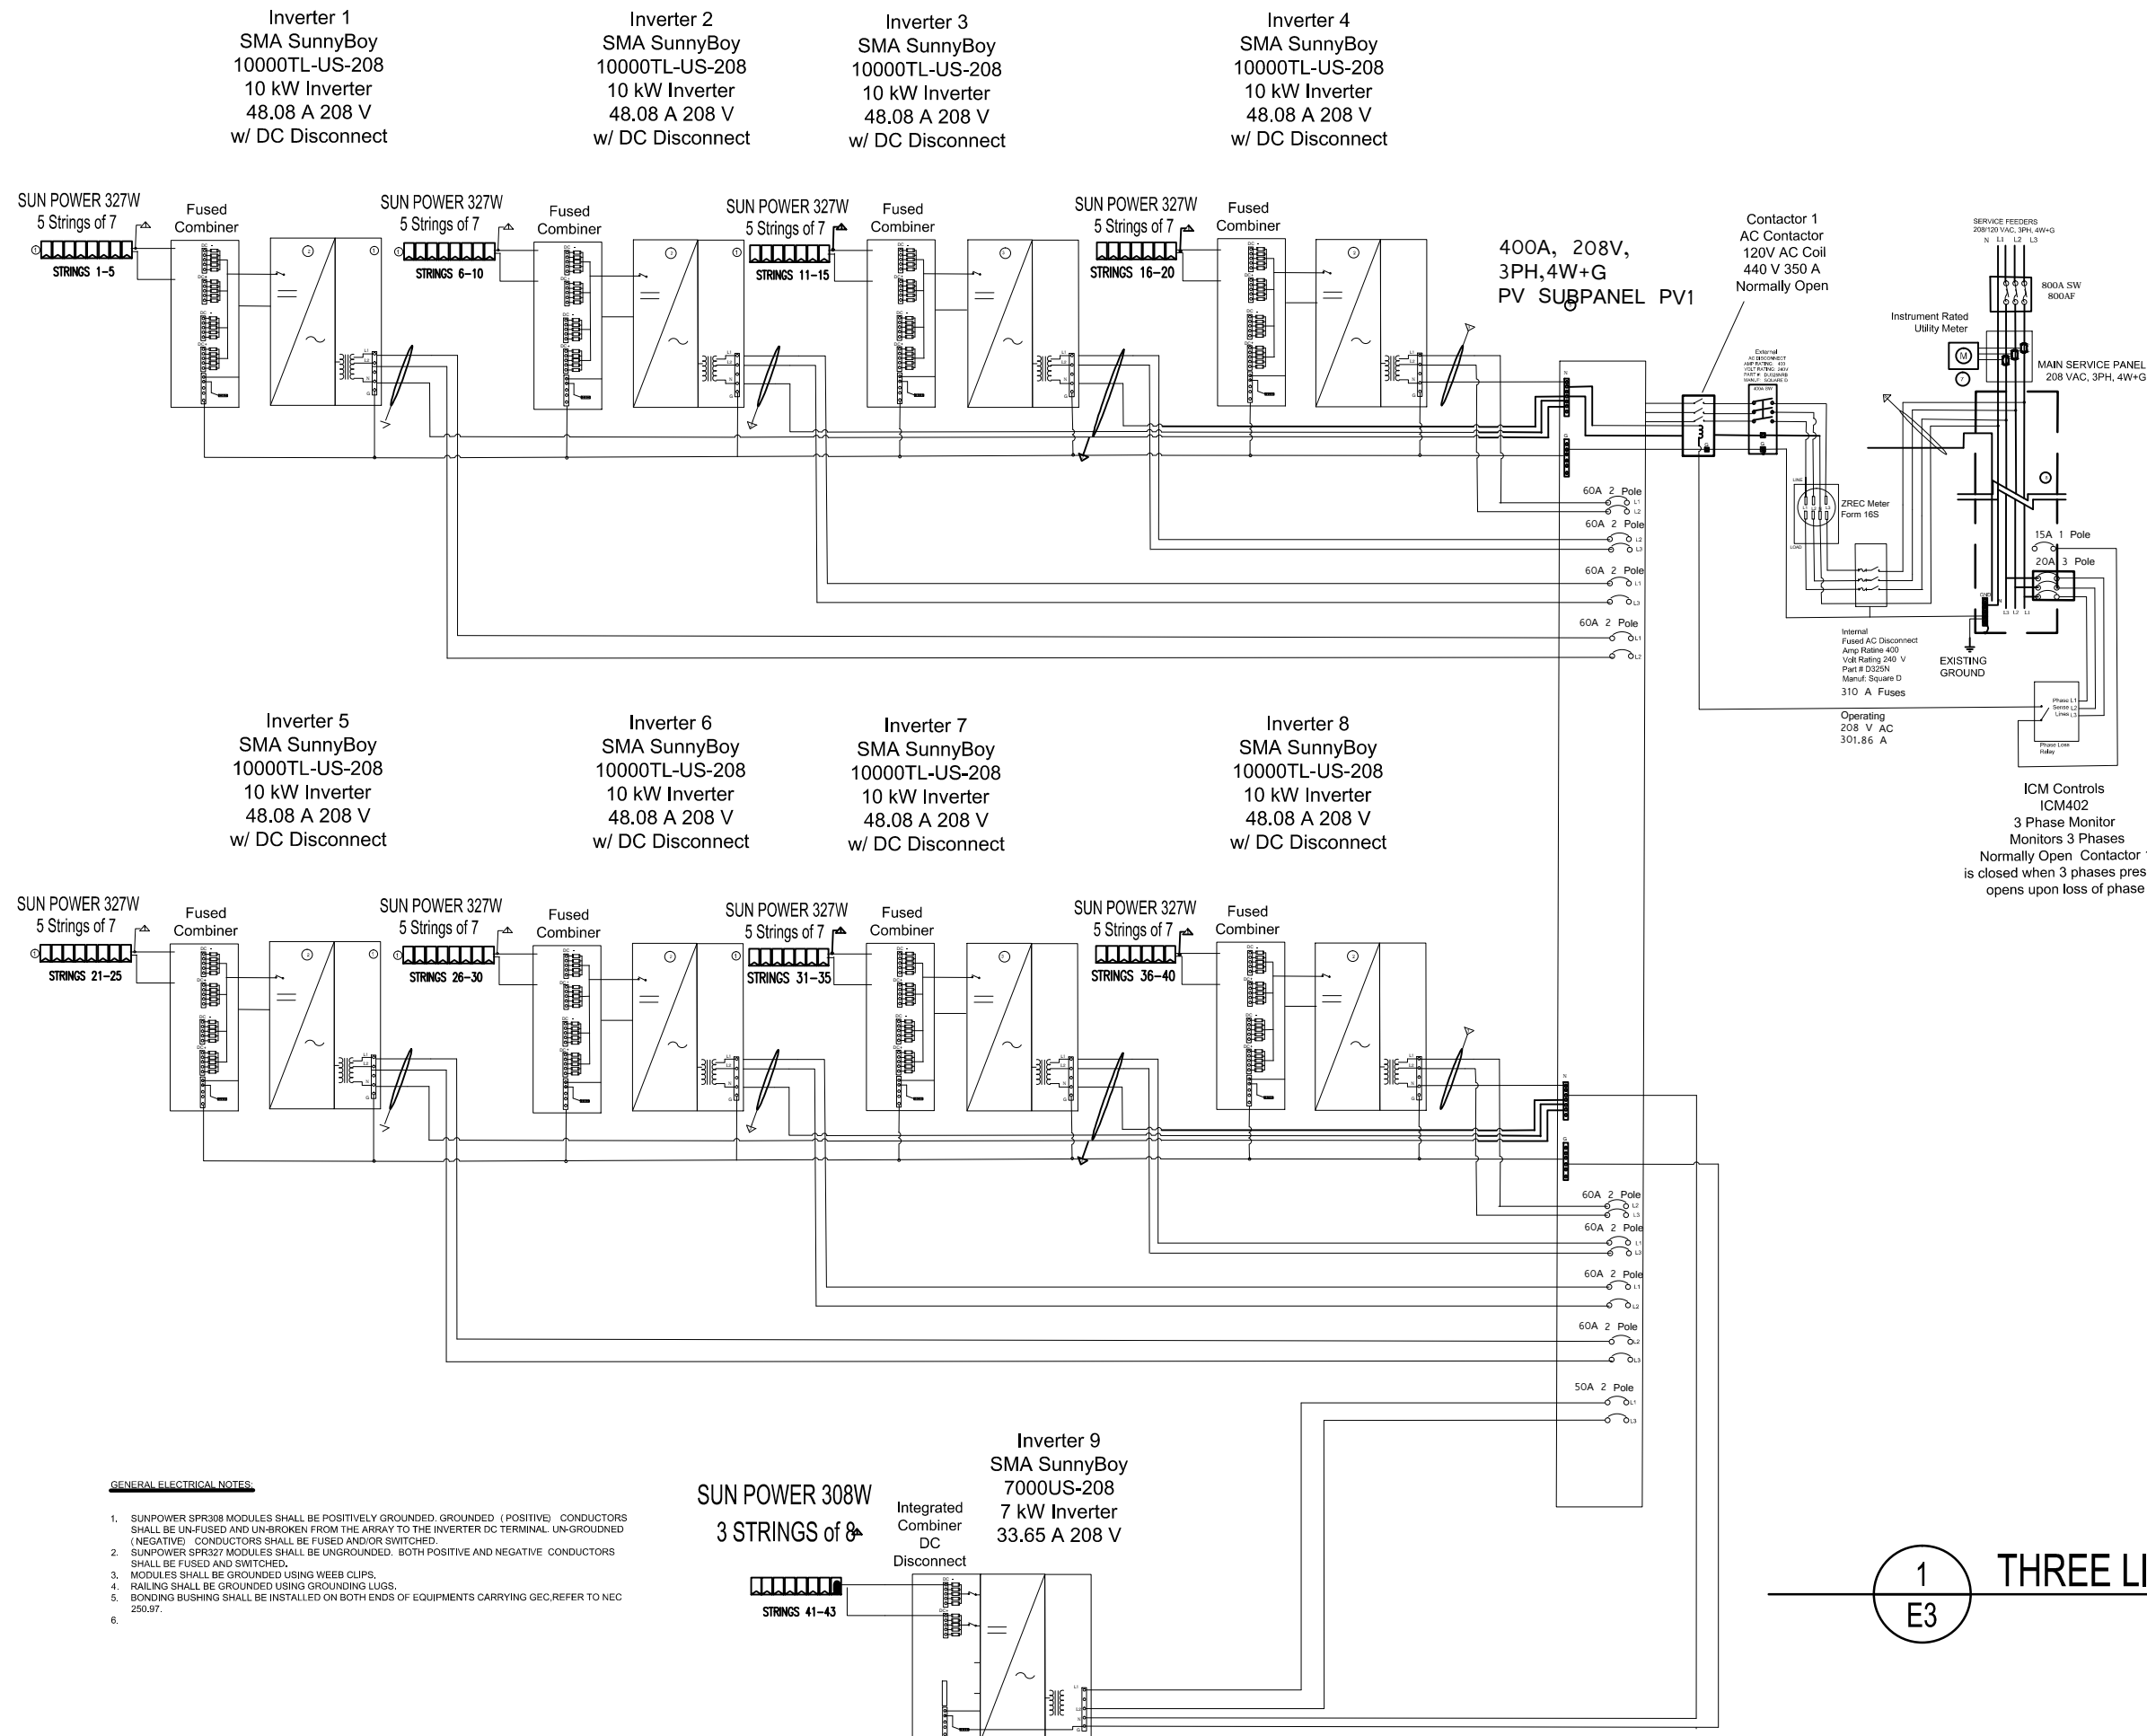

1  
E3 THREE LINE DIAGRAM